


1 Long Section
1 : 100



4 Front Elevation

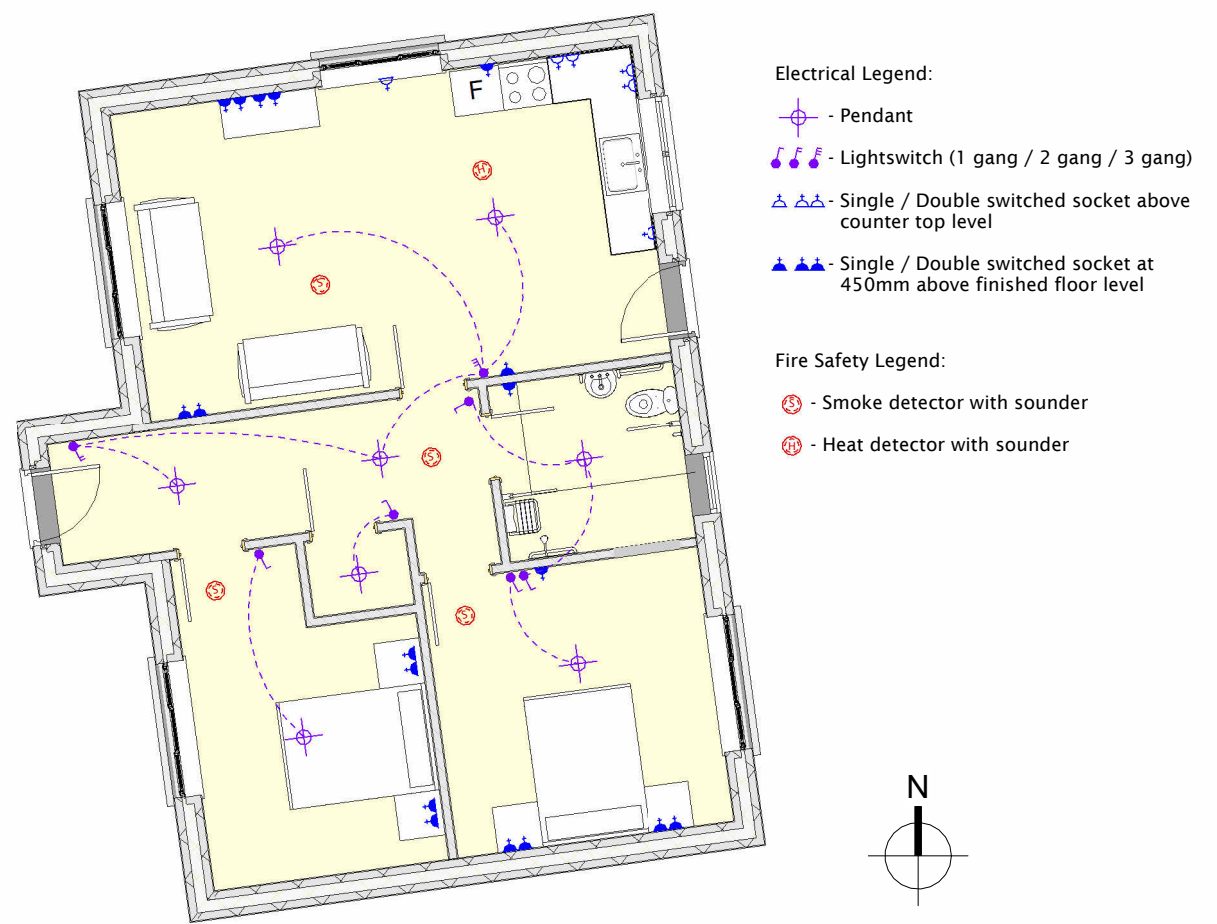

3 Electrical Floor Plan
1 : 100



2 Cross Section
1 : 100

PLANNING

Note:
Use figured dimensions only: do not scale drawings -Read in conjunction with specification and consultant's drawings -Report any discrepancies in drawings to architect and obtain instructions before putting work in hands -Check all dimensions on site -This drawing is copyright © 2023 of TA Group, Corrahoor, Kiltimagh, Mayo, and may not be reproduced, in whole or part, without TA Group prior consent.

No	Date	Description	Issued by	Issued to
00	10.03.2023	Issued for review	RW	LCC
01	19.04.2023	Floor plan flipped and moved on site	RW	LCC

<p>Corrahoor, Kiltimagh, Co. Mayo, P12 Y6V0 tcampbell@tagroup.ie 094 904 1049 www.tagroup.ie www.linkedin.com/company/tagroup-ire</p>	<p>Corrahoor, Kiltimagh, Co. Mayo, P12 Y6V0 www.tagroup.ie</p>		<p>Project: New Dwelling Corneddan, Ballinalee, Longford</p>		<p>Drawn by: RW</p>		<p>Checked by: TC</p>	
	<p>Client: Longford County Council</p>		<p>Date: 19.04.2023</p>		<p>Project number: 22,097</p>		<p>Scale: 1 : 100</p>	
<p>Sheet: Sections</p>		<p>Dwg No: P-30-01</p>		<p>Rev: 01</p>		<p>Printed on: 01/06/2023 11:07:49</p>		