


- NOTES:**
1. FIGURED DIMENSIONS ONLY TO BE TAKEN FROM THIS DRAWING.
 2. ALL DRAWINGS TO BE CHECKED BY THE CONTRACTOR ON SITE.
 3. ENGINEER/EMPLOYERS REPRESENTATIVE, AS APPROPRIATE, TO BE INFORMED BY THE CONTRACTOR OF ANY DISCREPANCIES BEFORE ANY WORK COMMENCES.
 4. THE CONTRACTOR SHALL UNDERTAKE A THOROUGH CHECK FOR THE ACTUAL LOCATION OF ALL SERVICES/UTILITIES, ABOVE AND BELOW GROUND, BEFORE ANY WORK COMMENCES.
 5. ALL LEVELS SHOWN RELATE TO ORDNANCE SURVEY DATUM AT MALIN HEAD.


FINAL SUDS DESIGN TO BE AGREED WITH LONGFORD COUNTY COUNCIL.

THE INFORMATION ON THIS DRAWING IS TO THE ORDNANCE SURVEY IRELAND ITM COORDINATE SYSTEM

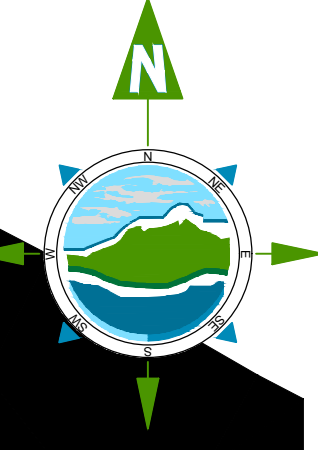

LEGEND:

- PLANNING BOUNDARY —
- EXISTING FOUL PIPE —
- EXISTING FOUL MANHOLE ●
- EXISTING SURFACE WATER PIPE —
- EXISTING SURFACE WATER MANHOLE ■
- PROPOSED FOUL PIPE —
- PROPOSED FOUL MANHOLE ○
- PROPOSED SURFACE WATER PIPE —
- PROPOSED SURFACE WATER MANHOLE ■
- PROPOSED PERMEABLE SURFACING TO LANDSCAPE ARCHITECTS FINISH
- PROPOSED SOAKAWAY
- PROPOSED PERFORATED PIPE —
- PROPOSED TREE PIT
- INSPECTION CHAMBER AS PER Uisce Eireann Details ■
- ACCESS CHAMBERS 450mm X 450mm OPENING, 500-900mm DEEP. ■

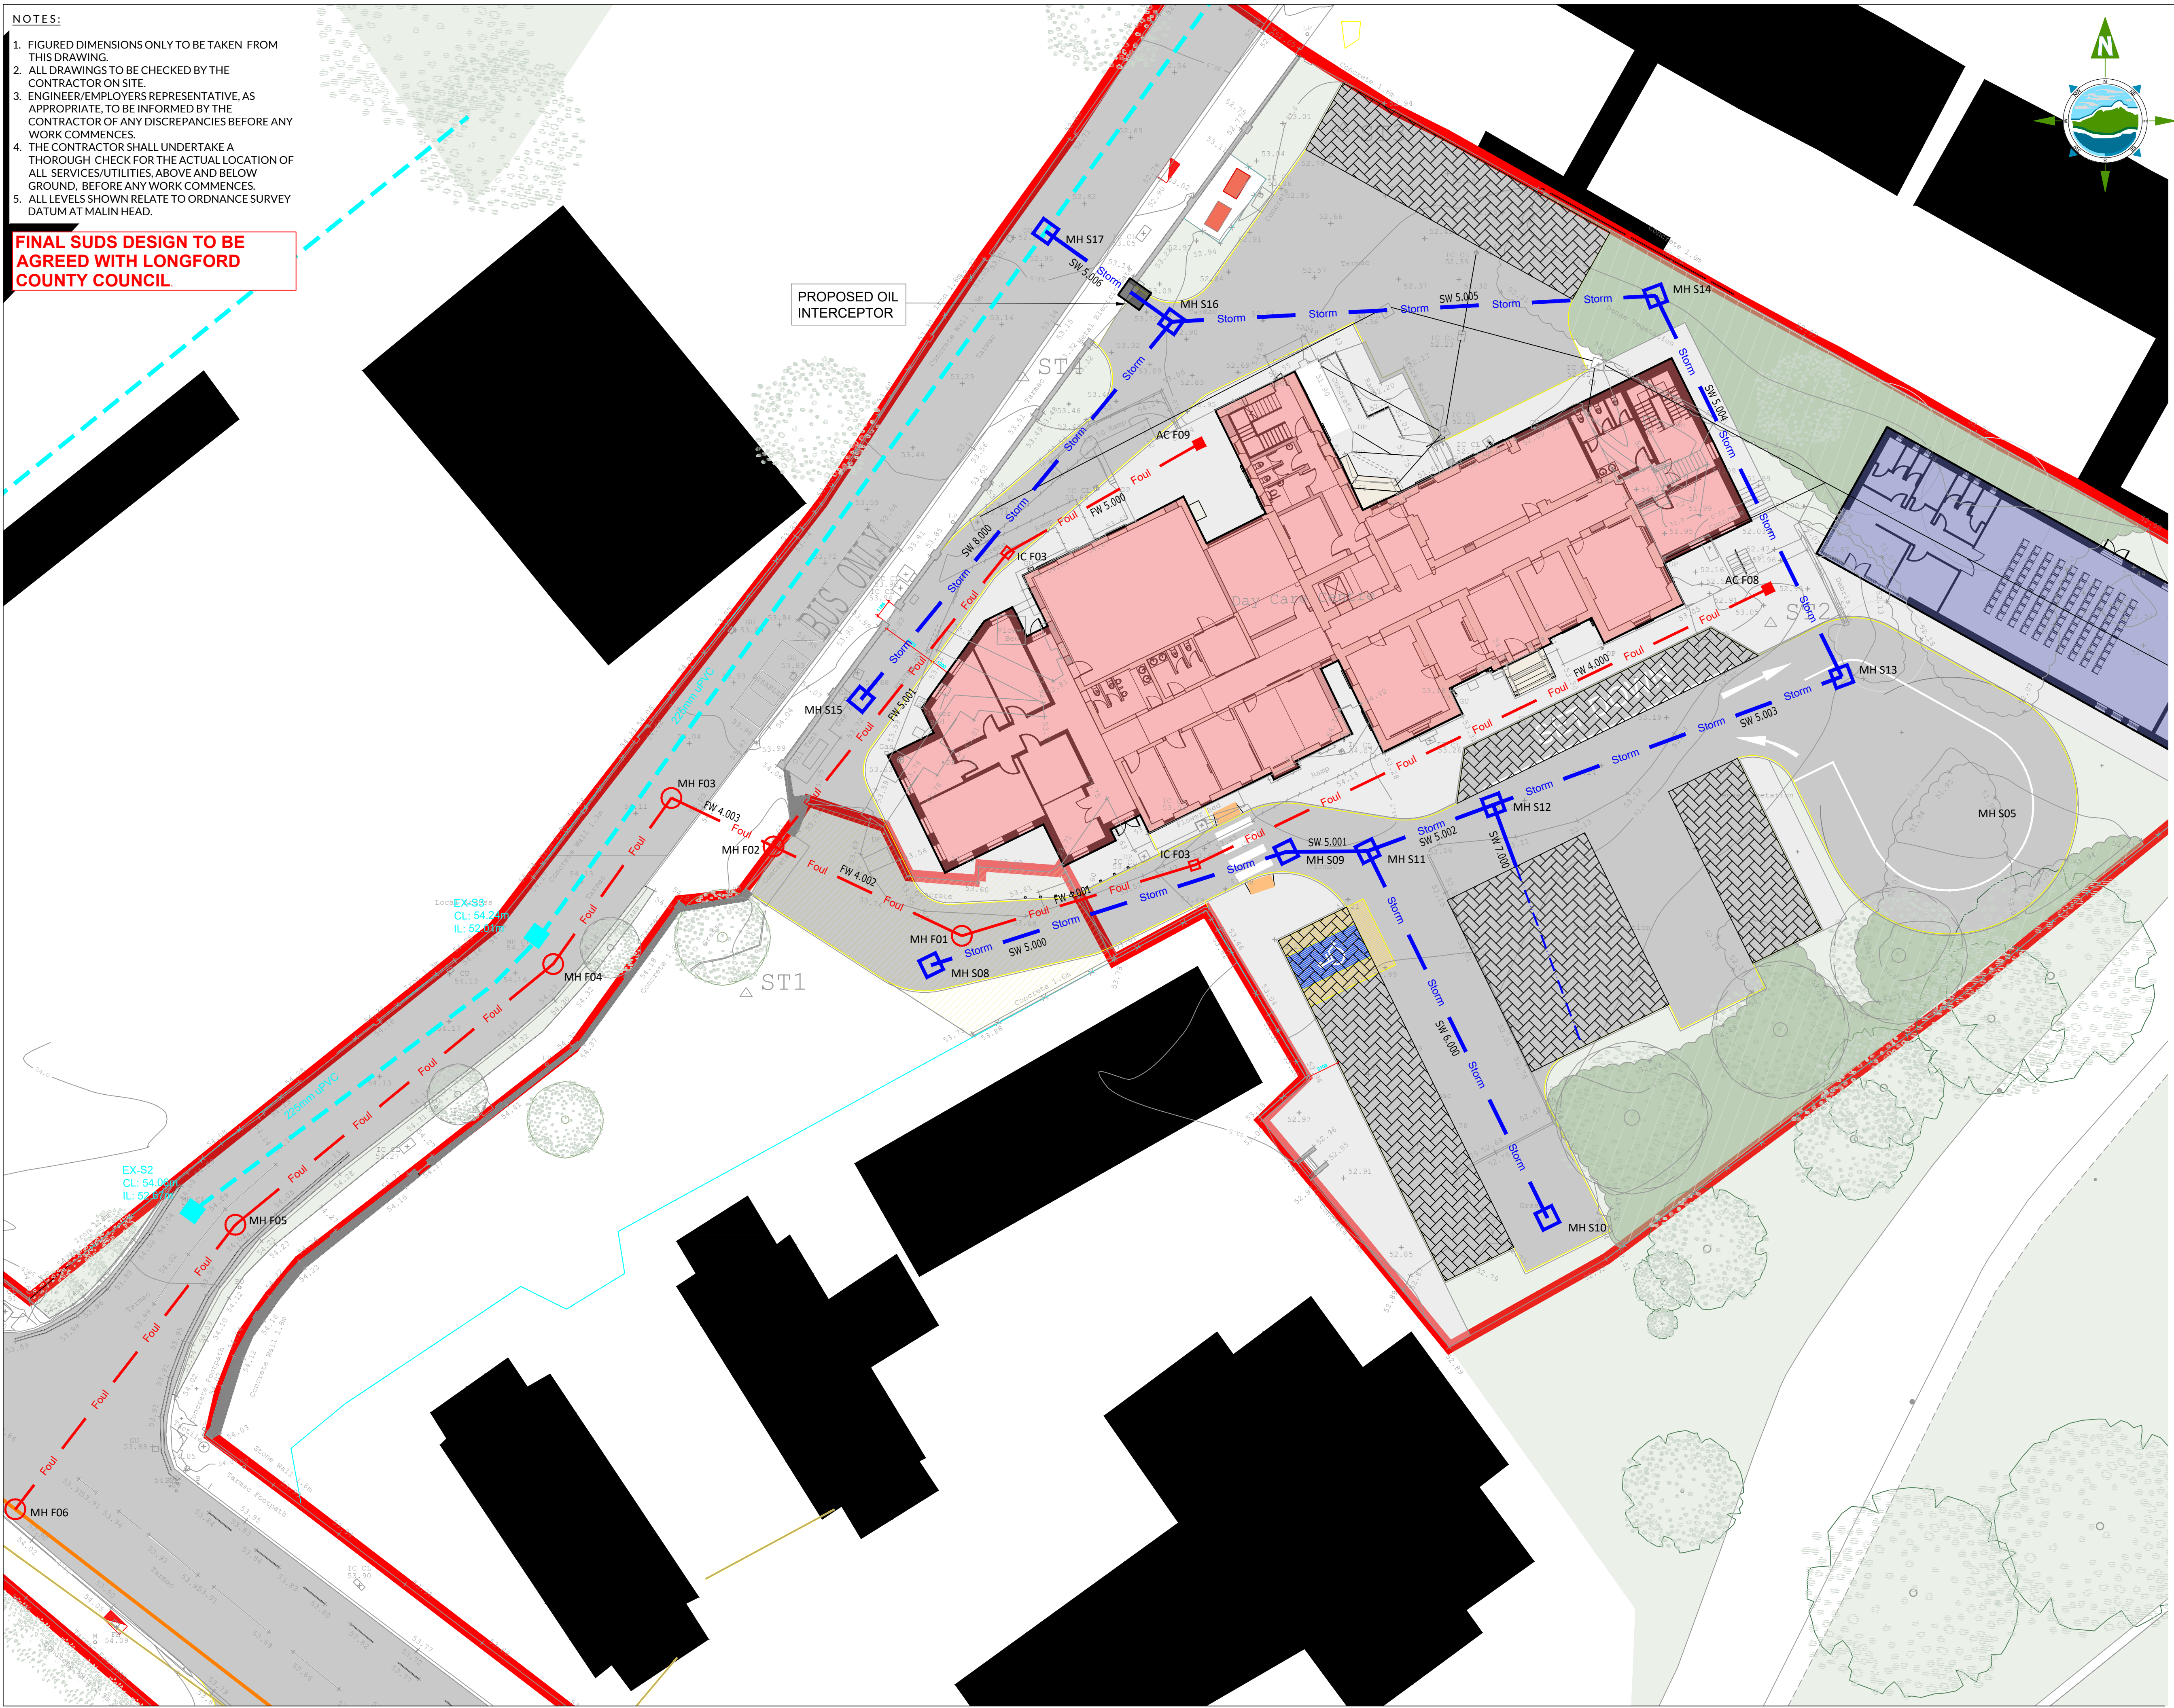

Rev	Date	Description	By	Chkd.
P01	15/03/2024	ISSUED FOR PLANNING	PF	MC

Client:

Project: **POBAILLE CHEILE REGENERATION PROJECT**

Title: **PROPOSED DRAINAGE LAYOUT CONVENT DAY CARE CENTRE**

Scale @ A1: **1:100**
 Prepared by: P. FANNING Checked by: M. CASEY Date: 15/03/2024
 Drawing Status: **PLANNING**

TOBIN
 Tel: +353 (0)91 565 211
 Email: info@tobin.ie
 www.tobin.ie

Drawing No.: **11560-2012** Revision: **P01**