


NOTES:

1. FIGURED DIMENSIONS ONLY TO BE TAKEN FROM THIS DRAWING.
2. ALL DRAWINGS TO BE CHECKED BY THE CONTRACTOR ON SITE.
3. ENGINEER/EMPLOYERS REPRESENTATIVE, AS APPROPRIATE, TO BE INFORMED BY THE CONTRACTOR OF ANY DISCREPANCIES BEFORE ANY WORK COMMENCES.
4. THE CONTRACTOR SHALL UNDERTAKE A THOROUGH CHECK FOR THE ACTUAL LOCATION OF ALL SERVICES/UTILITIES, ABOVE AND BELOW GROUND, BEFORE ANY WORK COMMENCES.
5. ALL LEVELS SHOWN RELATE TO ORDNANCE SURVEY DATUM AT MALIN HEAD.

FINAL SUDS DESIGN TO BE AGREED WITH LONGFORD COUNTY COUNCIL.

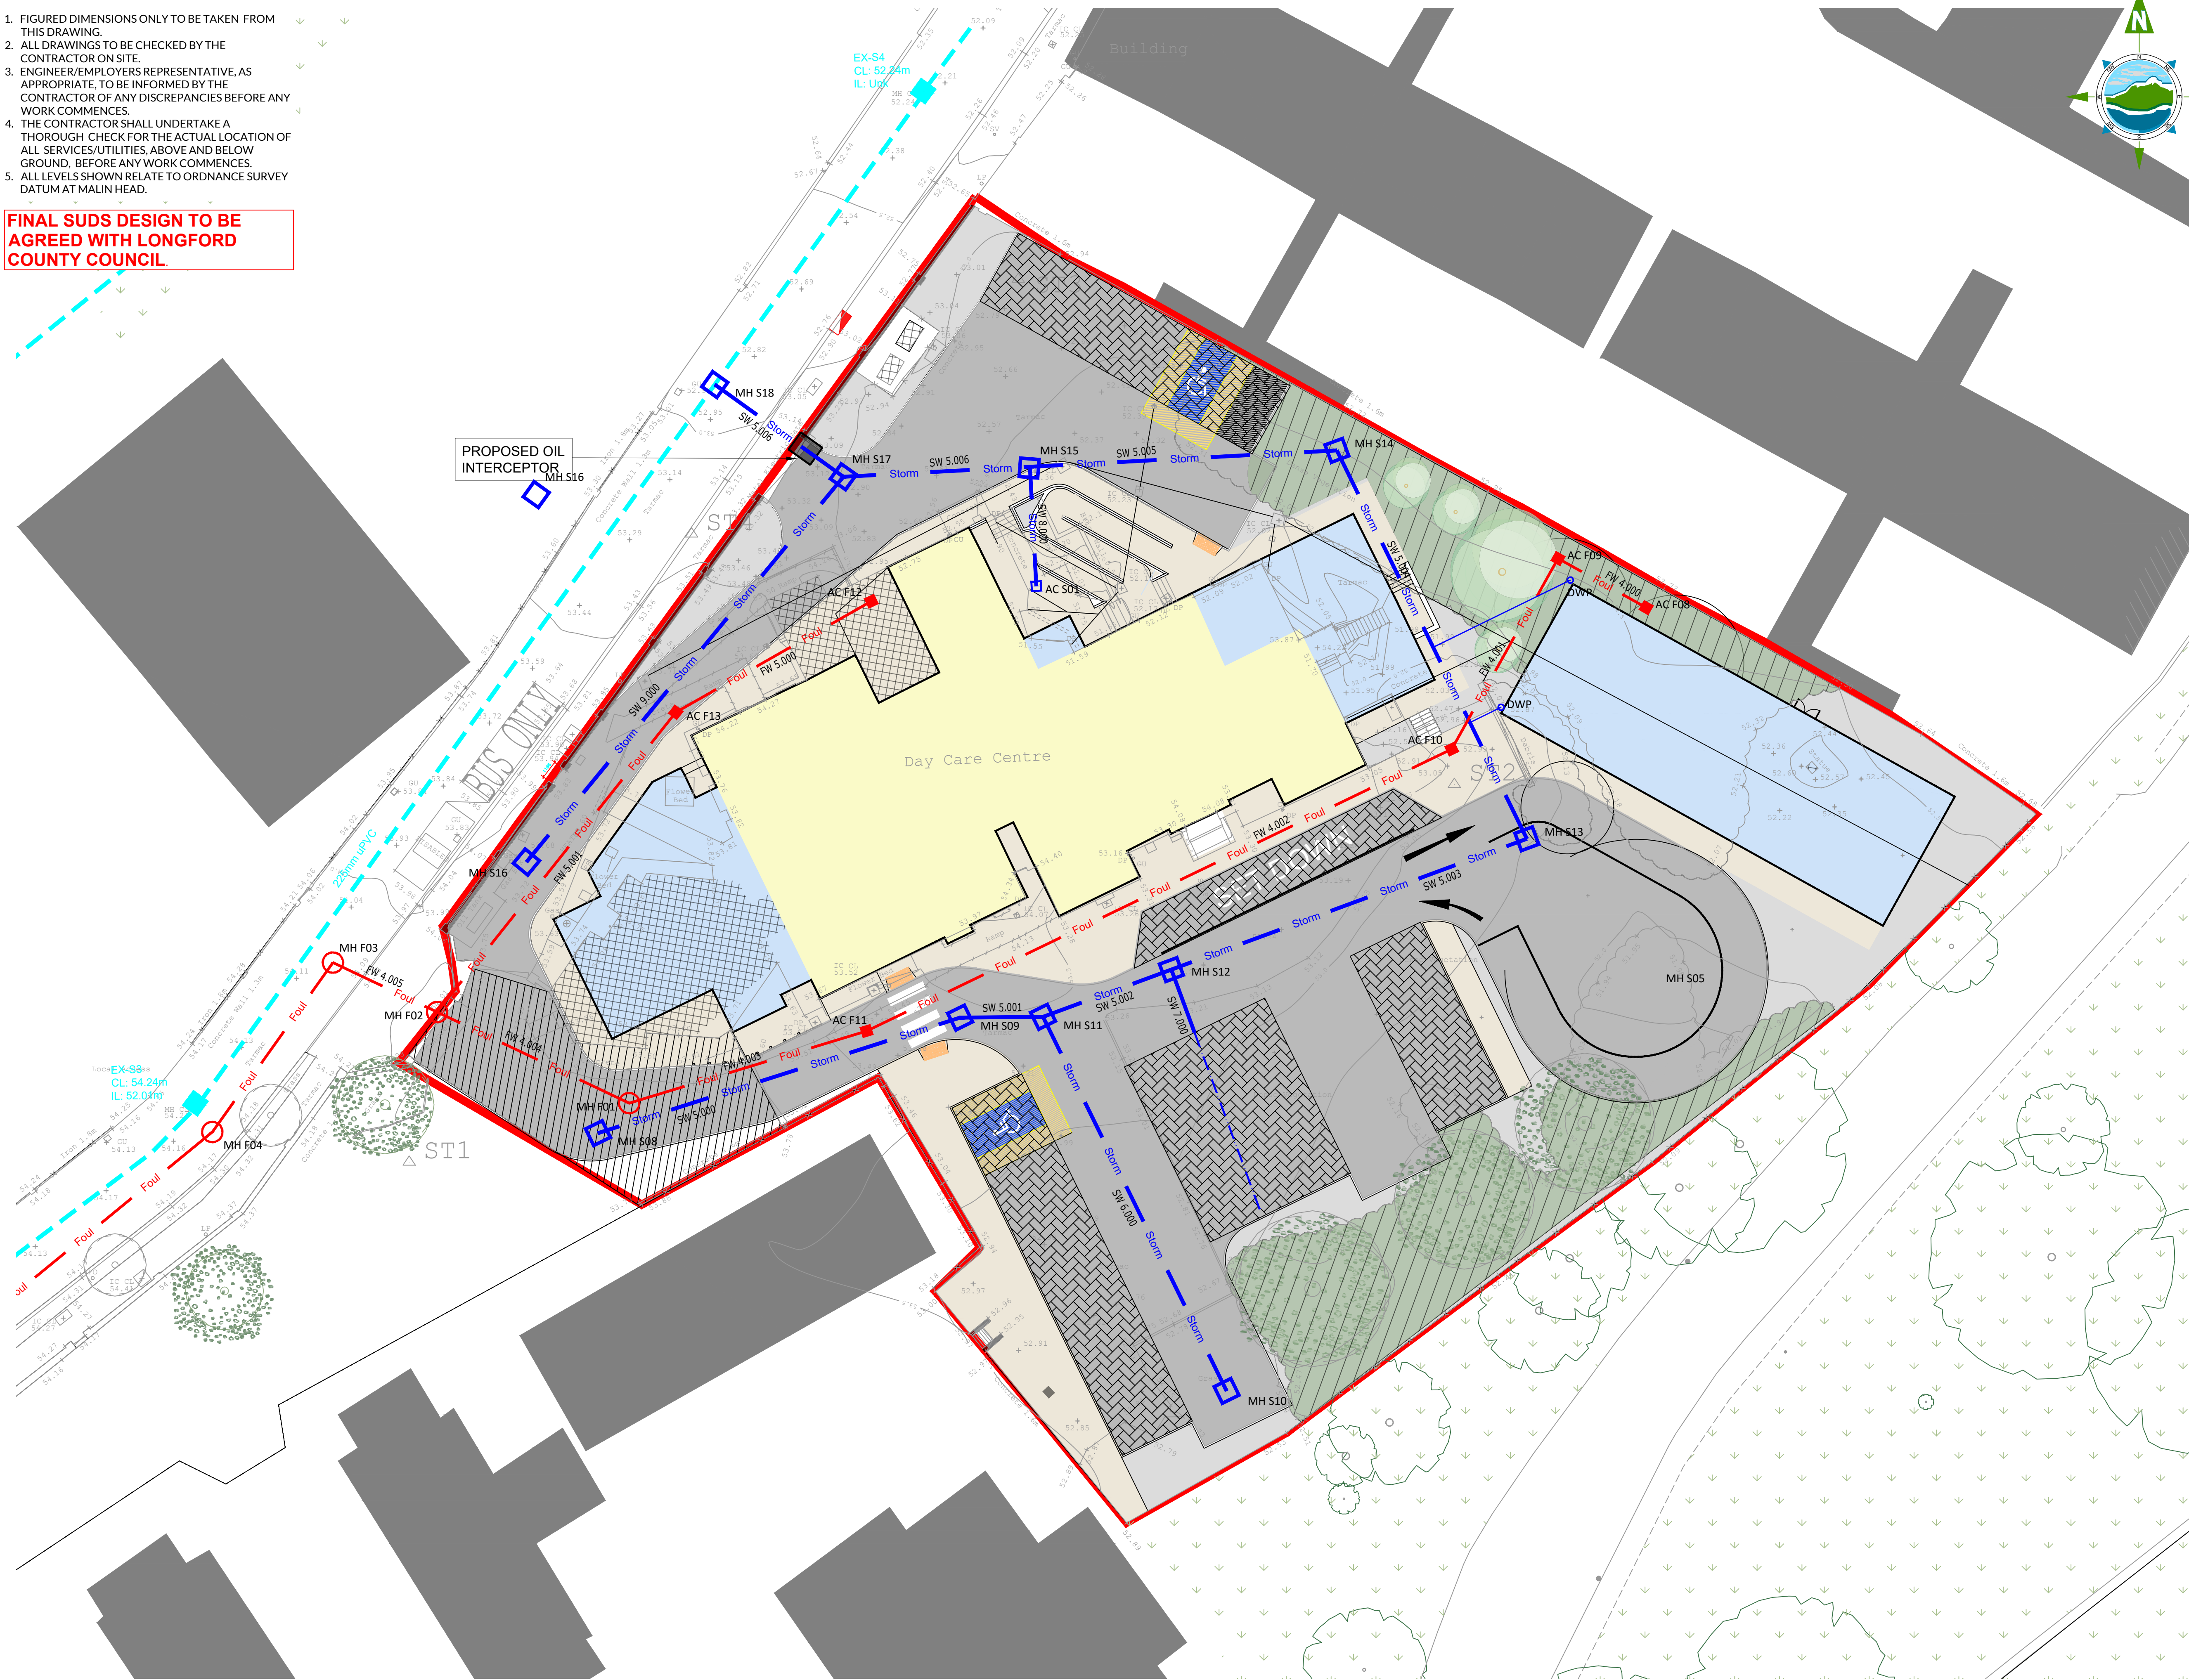

THE INFORMATION ON THIS DRAWING IS TO THE ORDNANCE SURVEY IRELAND ITM COORDINATE SYSTEM

LEGEND:

- PLANNING BOUNDARY
- EXISTING FOUL PIPE
- EXISTING FOUL MANHOLE
- EXISTING SURFACE WATER PIPE
- EXISTING SURFACE WATER MANHOLE
- PROPOSED FOUL PIPE
- PROPOSED FOUL MANHOLE
- PROPOSED SURFACE WATER PIPE
- PROPOSED SURFACE WATER MANHOLE
- PROPOSED PERMEABLE SURFACING TO LANDSCAPE ARCHITECTS FINISH
- PROPOSED SOAKAWAY
- PROPOSED PERFORATED PIPE
- PROPOSED TREE PIT
- INSPECTION CHAMBER AS PER UISCÉ EIREANN DETAILS
- ACCESS CHAMBERS 450mm X 450mm OPENING. 500-900mm DEEP.

P01	30/04/2025	ISSUED FOR PLANNING	YM	PF
Rev	Date	Description	By	Chkd.

Client:



Project:

POBAILLE CHEILE REGENERATION PROJECT

Title:

PROPOSED DRAINAGE LAYOUT
CONVENT DAY CARE CENTRE

Scale @ A1:

1:200

Prepared by:

Checked by:

Date:

Y.MANSOOR

P.FANNING

30/04/2025

Drawing Status:

PLANNING

TOBIN

Tel: +353 (0)91 565 211
Email: info@tobin.ie
www.tobin.ie

Drawing No.:

Revision:

11560-2010

P01